

WITH (2) # VDL18 3/2 DII
 NEW LOCATION
 FRAME 2X4 16" OC STUDS
 (2) 2 X 10 HEADER (TYP)

1-4" X 3'-2" CASEMENT FLANKERS
 3'-0" X 3'-2" PICTURE UNIT C/L ALIGNS WITH SINK
 REFRAME 2X4 16" OC STUD WALL AS NEC.
 (2) 2X10 HEADER OR EQUIVALENT

ABSOLUTE GREEN HOMES INC
 35 TRILLIUM LAKE DRIVE
 FOUNTAIN HILLS, CT 06030
 PHONE 860.429.0088
 FAX 860.429.0094
 WWW.ABSOLUTEGREENHOMES.COM
 LICENSE # 06-029194
 CONNECTICUT LIC 06066693



- DRAWING INDEX
- 1 EXISTING PLAN
 - 2 PROPOSED PLAN
 - 3 ELEVATION 1 TO 3
 - 4 ELEVATION 4 TO 9

REVISIONS	DATE
PLAN UPDATE	8-5-08
PLAN UPDATE	8-6-08
PLAN UPDATE	8-9-08
PLAN UPDATE	8-20-09
PLAN UPDATE	8-18-08
PLAN UPDATE	8-18-08
PLAN UPDATE	8-18-08
PLAN UPDATE	8-18-08
PLAN UPDATE	8-18-08
PLAN UPDATE	8-18-08
PLAN UPDATE	8-18-08
PLAN UPDATE	8-22-08

PROPOSED KITCHEN PLANS FINAL

PROJECT DESCRIPTION
 FULL KITCHEN REMODEL INCLUDING NEW
 CENTER ISLAND MUDROOM ENTRY BUILT IN
 DINING AREA FARM-SINK AND MAIL CENTER


ARCHITECT OF RECORD

DATE: 8-4-08
 SCALE: AS SHOWN
 DRAWN BY: RT/CK/CR/DP/CP

DRAWING #

2

PROPOSED KITCHEN

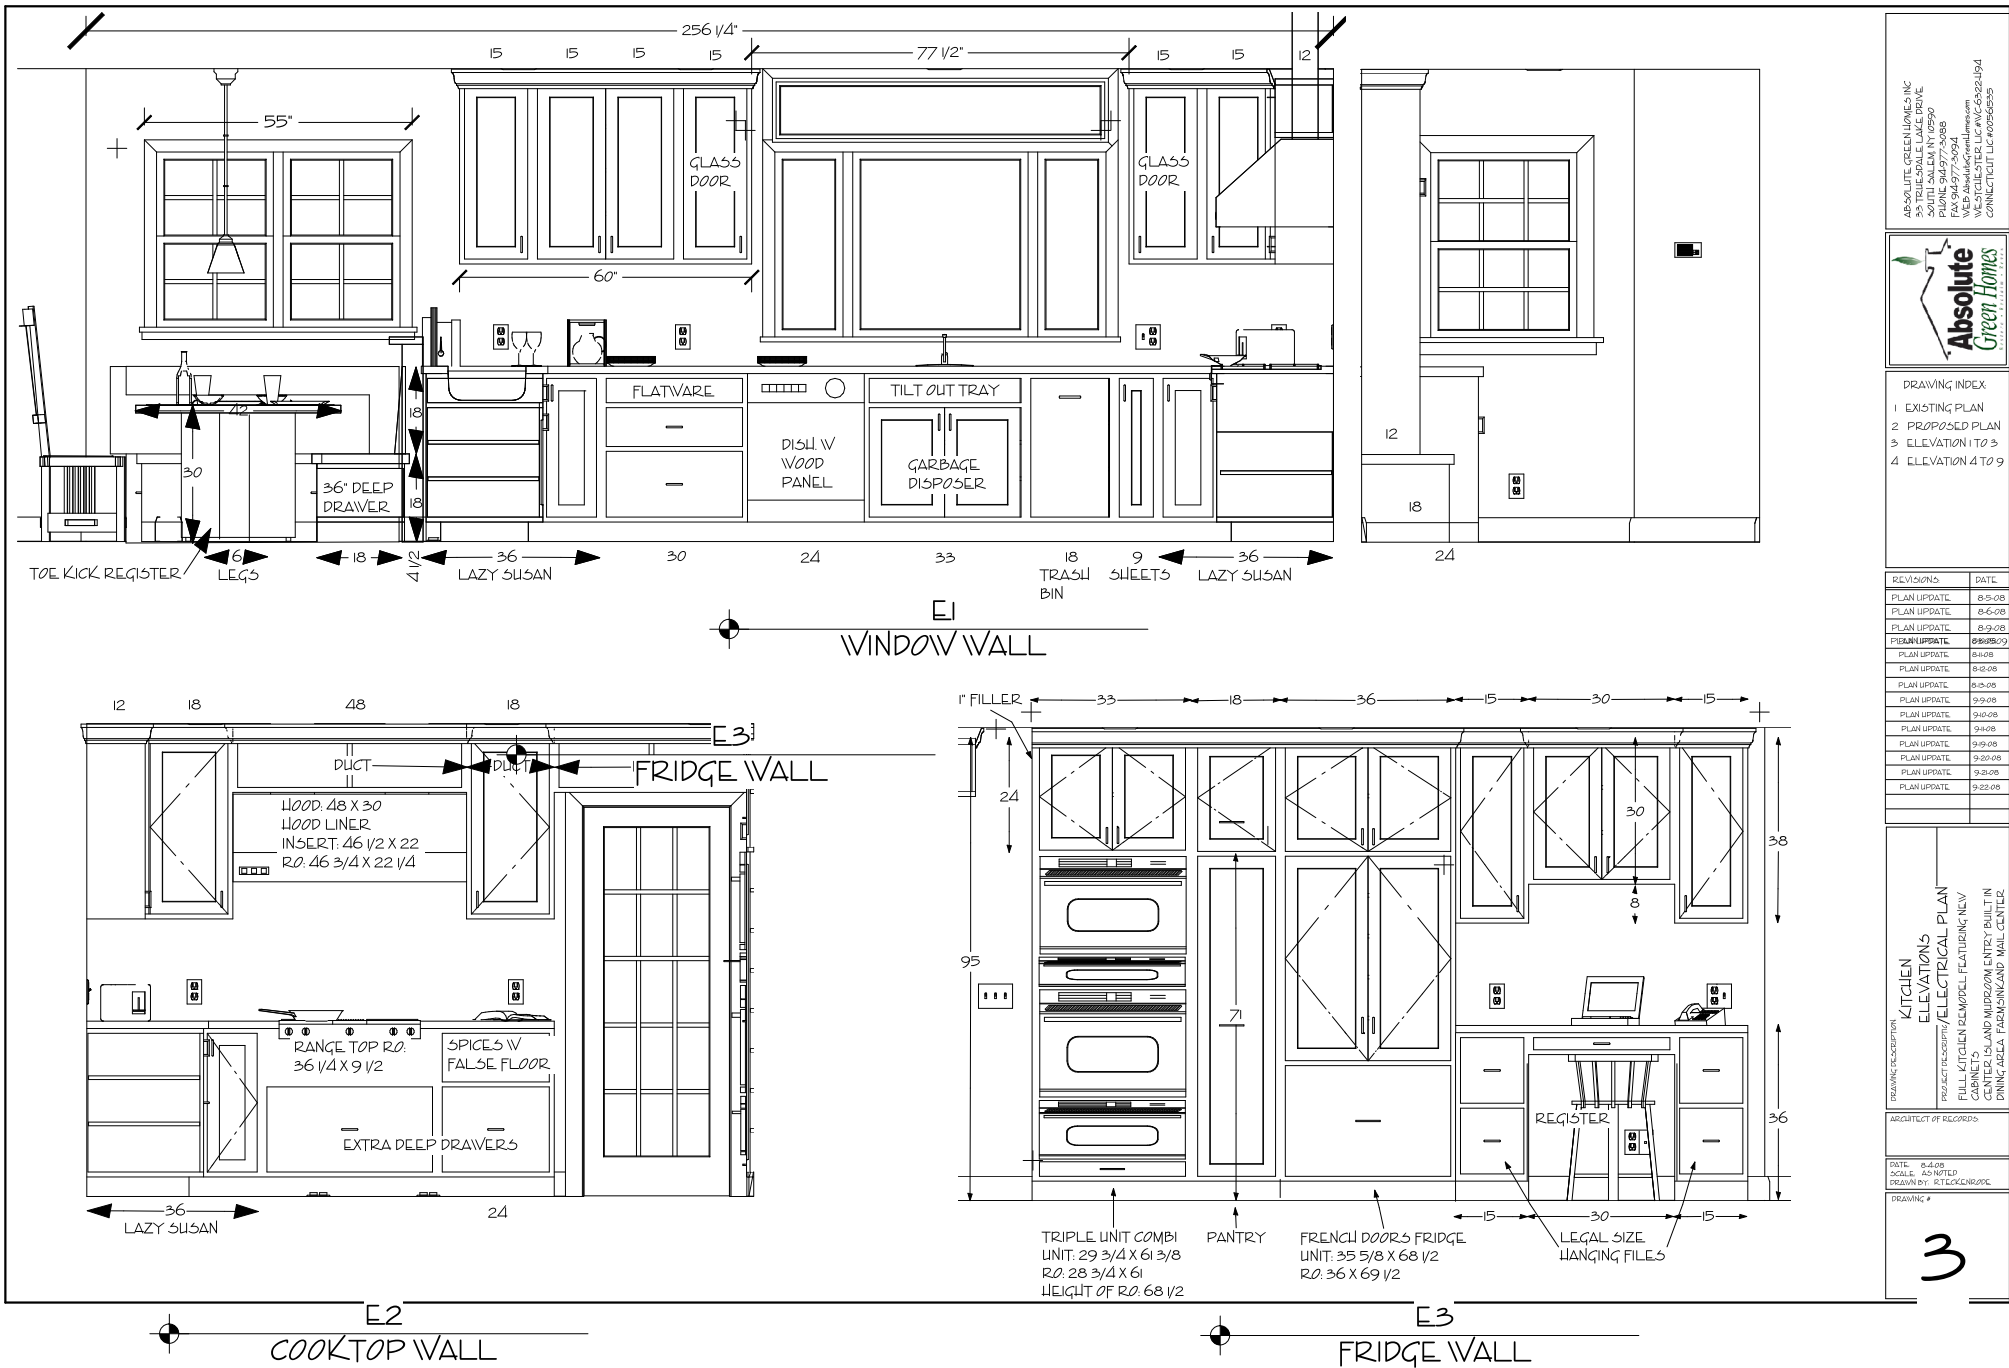

ABSOLUTE GREEN HOMES INC
 33 TRILLIUM LAKE DRIVE
 FOUNTAIN HILLS, IN 46990
 PHONE: 317.431.0808
 FAX: 317.437.3094
 WEB: absolutegreenhomes.com
 CONNECTICUT: 46966699



- DRAWING INDEX
- EXISTING PLAN
 - PROPOSED PLAN
 - ELEVATION 1 TO 3
 - ELEVATION 4 TO 9


REVISIONS	DATE
PLAN UPDATE	8-5-08
PLAN UPDATE	8-6-08
PLAN UPDATE	8-9-08
PLAN UPDATE	8-9-08
PLAN UPDATE	8-10-08
PLAN UPDATE	8-24-08
PLAN UPDATE	8-25-08
PLAN UPDATE	9-9-08
PLAN UPDATE	9-10-08
PLAN UPDATE	9-10-08
PLAN UPDATE	9-23-08
PLAN UPDATE	9-23-08
PLAN UPDATE	9-23-08

DRAWING DESCRIPTION: KITCHEN ELEVATIONS / ELECTRICAL PLAN
 PROJECT DESCRIPTION: ELECTRICAL PLAN
 PROJECT LOCATION: FOUNTAIN HILLS, IN
 CENTER ISLAND KITCHEN ENTRY BUILT IN
 DINING AREA, FARM-SINK AND MAIL CENTER


ARCHITECT OF RECORD:
 DATE: 8-4-08
 SCALE: AS SHOWN
 DRAWN BY: RT/CKC/BJP/CK

DRAWING #


3

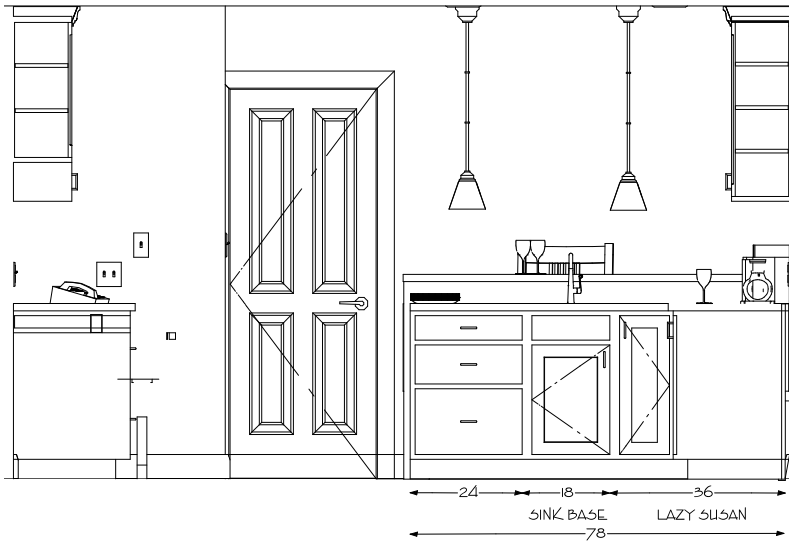

E4
PENINSULA

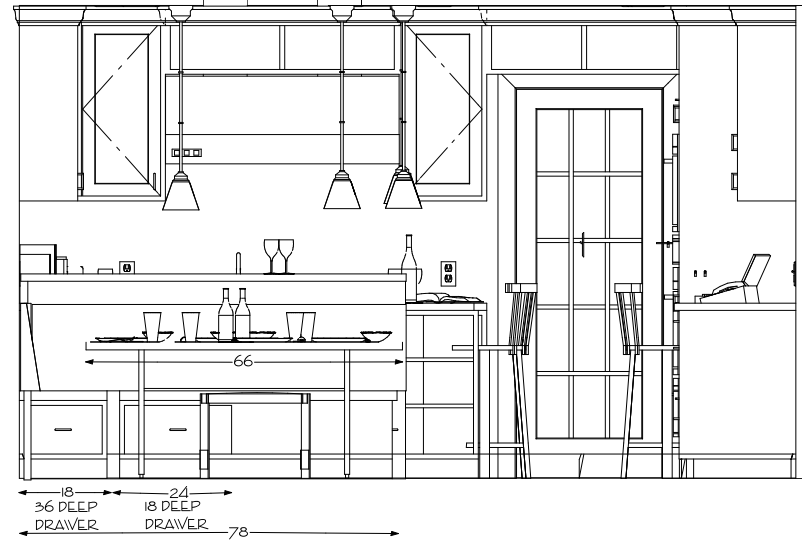


E5
EAT IN AREA

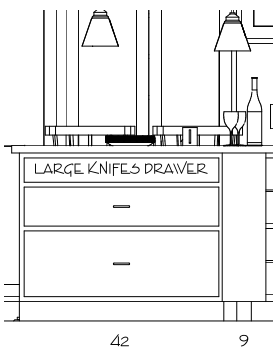


E6
FACING WINDOW



E7
FACING PENINSULA

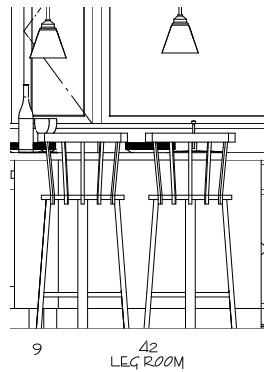

E8
FACING FRIDGE

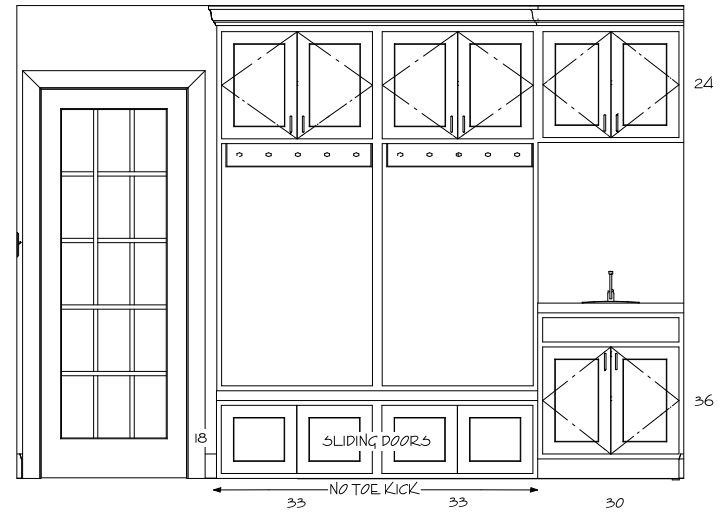

E9
MUD ROOM

ABSOLUTE GREEN HOMES INC
33 TRILLSDALE LAKE DRIVE
MIDDLEBURY, VT 05750
PHONE: 802.247.0088
FAX: 802.247.3094
WEB: absolutegreenhomes.com
024194
CONNECTICUT: 060666899



- DRAWING INDEX
1. EXISTING PLAN
 2. PROPOSED PLAN
 3. ELEVATION 1 TO 3
 4. ELEVATION 4 TO 9

REVISIONS	DATE
PLAN UPDATE	8-5-08
PLAN UPDATE	8-6-08
PLAN UPDATE	8-9-08
PLAN UPDATE	8-28-09
PLAN UPDATE	9-2-08
PLAN UPDATE	9-23-08

DRAWING DESCRIPTION
KITCHEN ELECTRICAL PLAN
PROJECT DESCRIPTION
MILLER GREEN EMBROIDERY BUILDING NEW
CENTER ISLAND MUDROOM ENTRY BUILT IN
DINING AREA FARM-SINK AND MAIL CENTER

ARCHITECT OF RECORD:
DATE: 8-4-08
SCALE: AS SHOWN
DRAWN BY: RT/CK/CR/DP/CP

DRAWING #
4

This document was created with Win2PDF available at <http://www.daneprairie.com>.
The unregistered version of Win2PDF is for evaluation or non-commercial use only.